



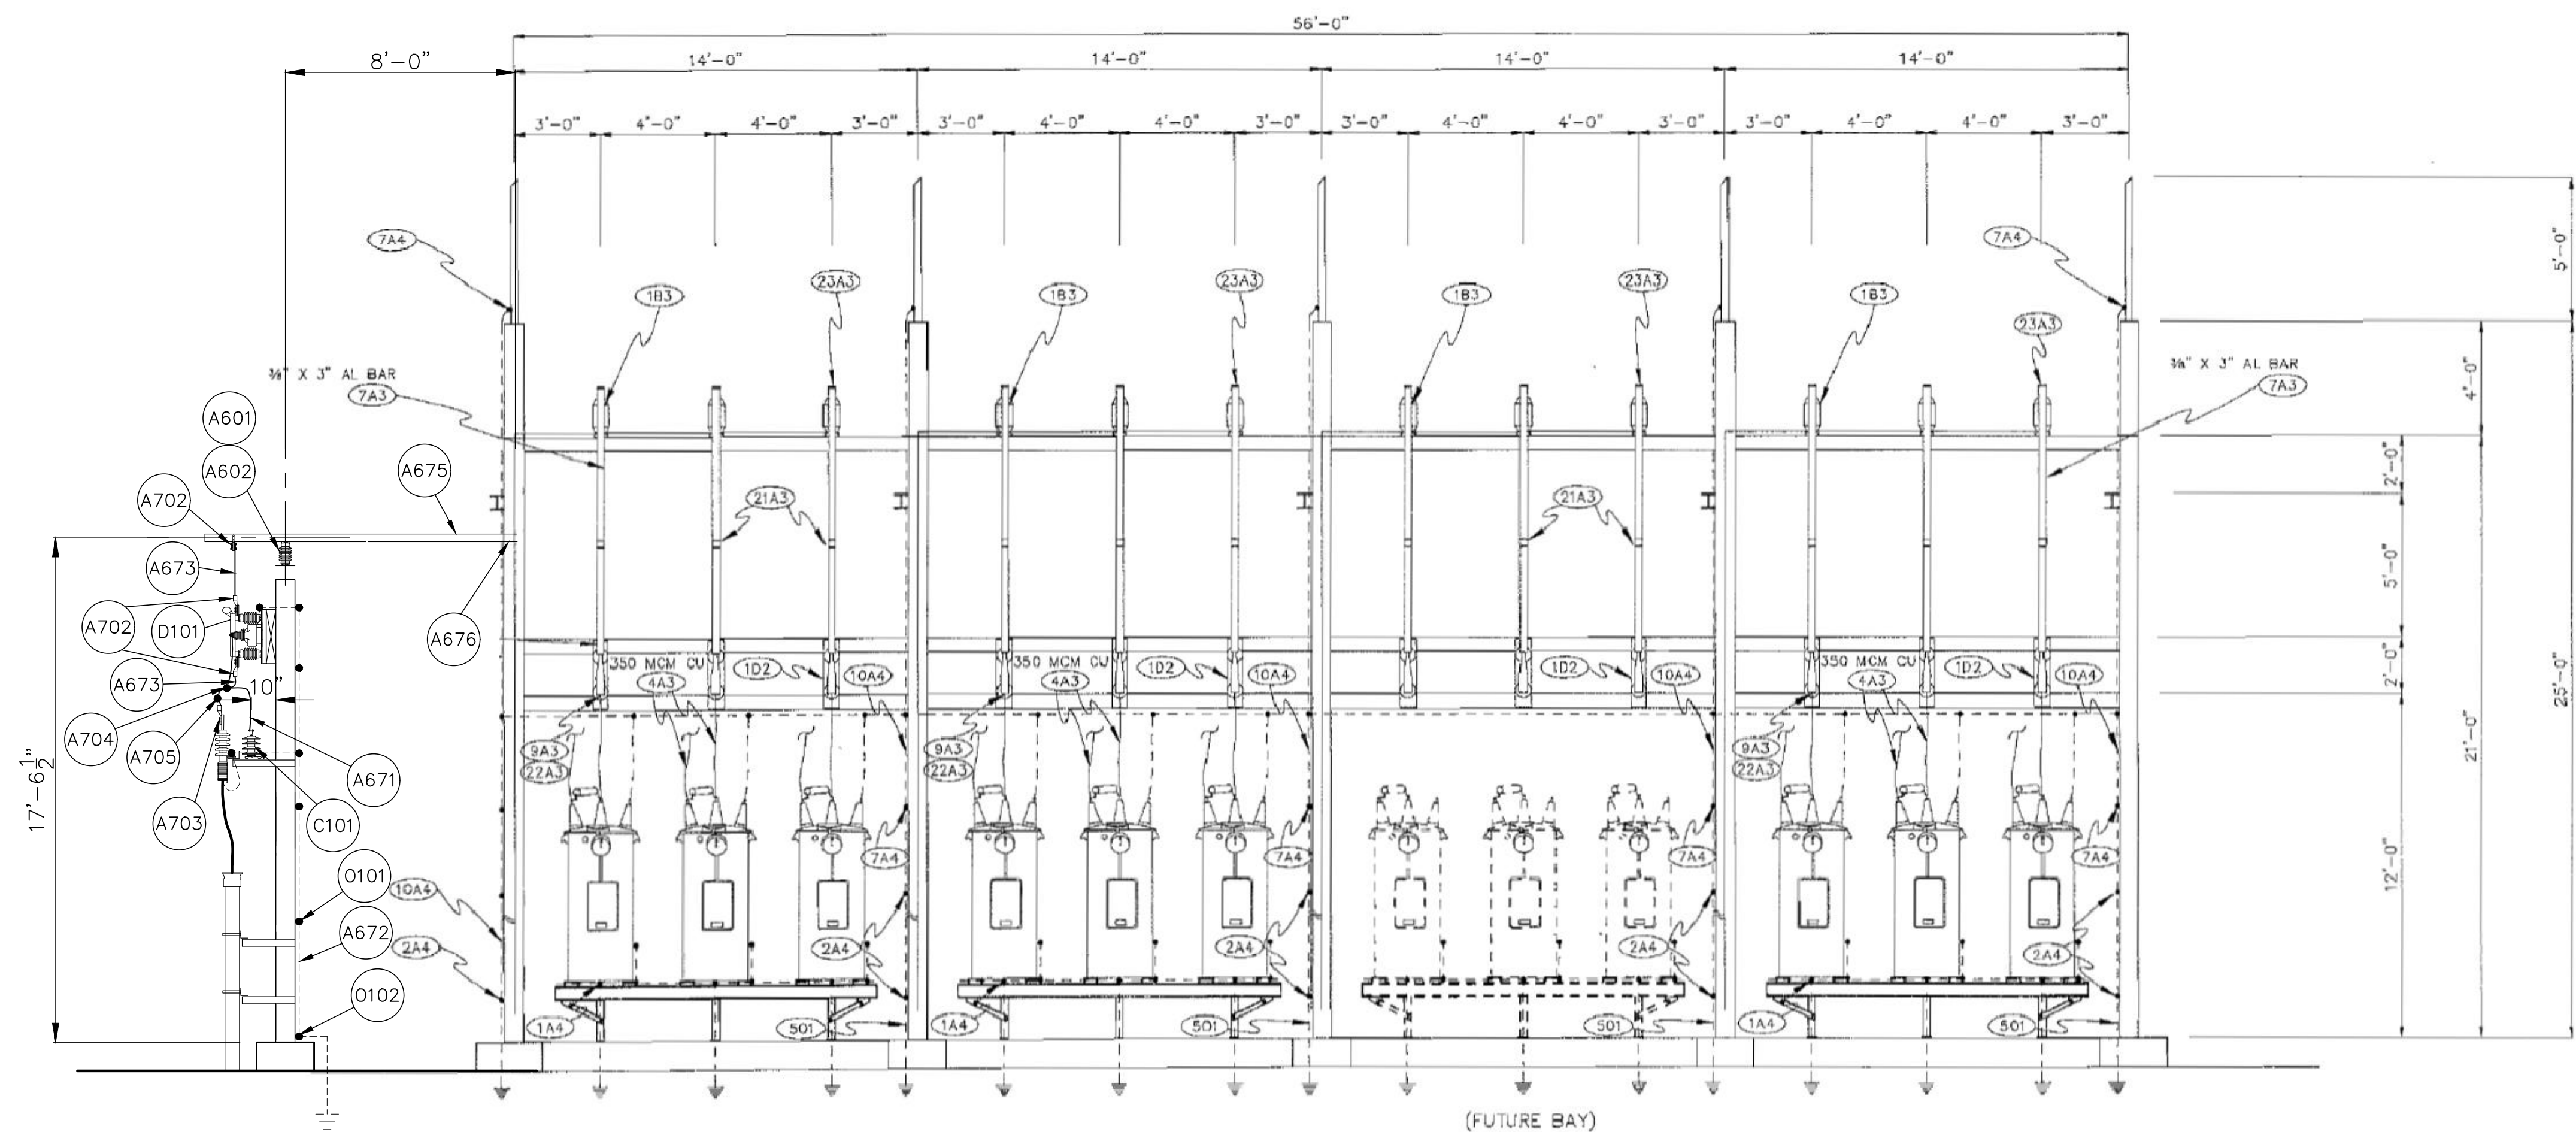

SECTION H-H

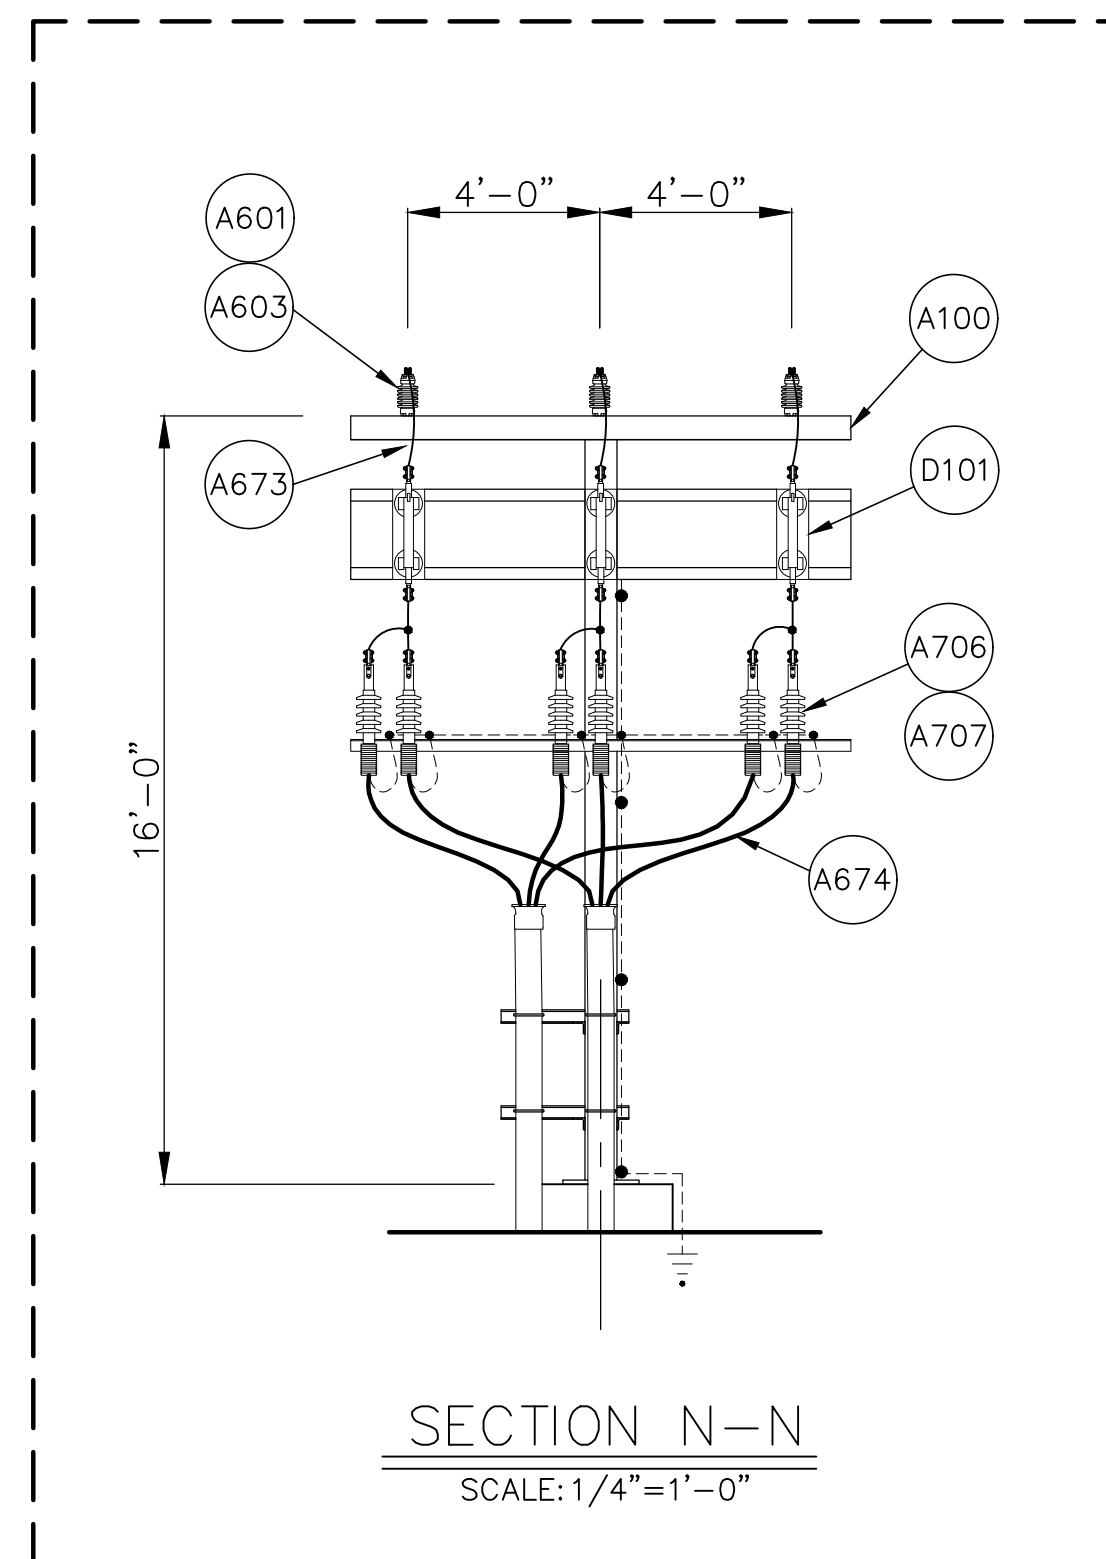

SECTION N-N
SCALE: 1/4"=1'-0"

1. MATERIALMAN/FABRICATOR VERIFY THAT CONDUCTOR TERMINAL PADS MATCH AND FIT ONTO SWITCH TERMINAL PADS (SIZE, NEMA RATING AND SHOULDER).
2. DIMENSIONS BASED ON ASSUMED ACCURACY OF EXISTING DRAWING SETS. ALL DIMENSIONS FOR NEW EQUIPMENT TO BE FIELD VERIFIED WITH ANY DISCREPANCIES BEING DISCUSSED WITH THE ENGINEER OF RECORD.

SITE PLAN _____ 11101S1
PLAN VIEW _____ 11101GA1
GILCHRIST ARMOUR _____ SL9310 SH.4
SE&D CORP. _____ 06-18-3508-GA-2

					CAPE HATTERAS ELECTRIC CO. BUXTON, NORTH CAROLINA AVON 115 TO 12.47 kV SUBSTATION SECTIONS Booth & Associates, LLC. 3611 Glenwood Avenue Raleigh, NC 27612 CONSULTING ENGINEERS NC F-0021
3/5/2020					
© 12/19	NO.	REVISIONS	DATE	DWN. JRT CKD. MFC SCALE: 1/4" = 1'-0"	DATE: 12/02/19 APPD. BWJ PLOT: 1:1
					DWG. NO. GA2 11101